



285 Palladio Pkwy.  
Folsom, CA 95630

550 SOUTH HOPE STREET  
SUITE 1950  
LOS ANGELES, CA 90071  
213.228.6900  
smithgroup.com

[illegible]

SEALS AND SIGNATURES

SEALS AND SIGNATURES

NOT FOR  
CONSTRUCTION

SHEET TITLE

## SIGNAGE LINES-OF SIGHT

|                |             |
|----------------|-------------|
| PROJECT NUMBER | [13931.000] |
|----------------|-------------|

SHEET NUMBER

### 1-A1.3.1



**NOTE:** Color materials board and renderings will be submitted prior to the public hearing



EXISTING



LEVEL 1 - SITE PLAN - LINES OF SIGHT  
SCALE: 1" = 100'-0"



**EXIST MONUMENT SIGNS (NO UPDATES)**



## NEW ENTRY MONUMENT GATEWAY SIGN




**NOTE:** Color materials board and renderings will be submitted prior to the public hearing

**BUILDING MOUNTED SIGNS (SAMPLE IMAGE BELOW)**



**NOTE:** Color materials board and renderings will be submitted prior to the public hearing

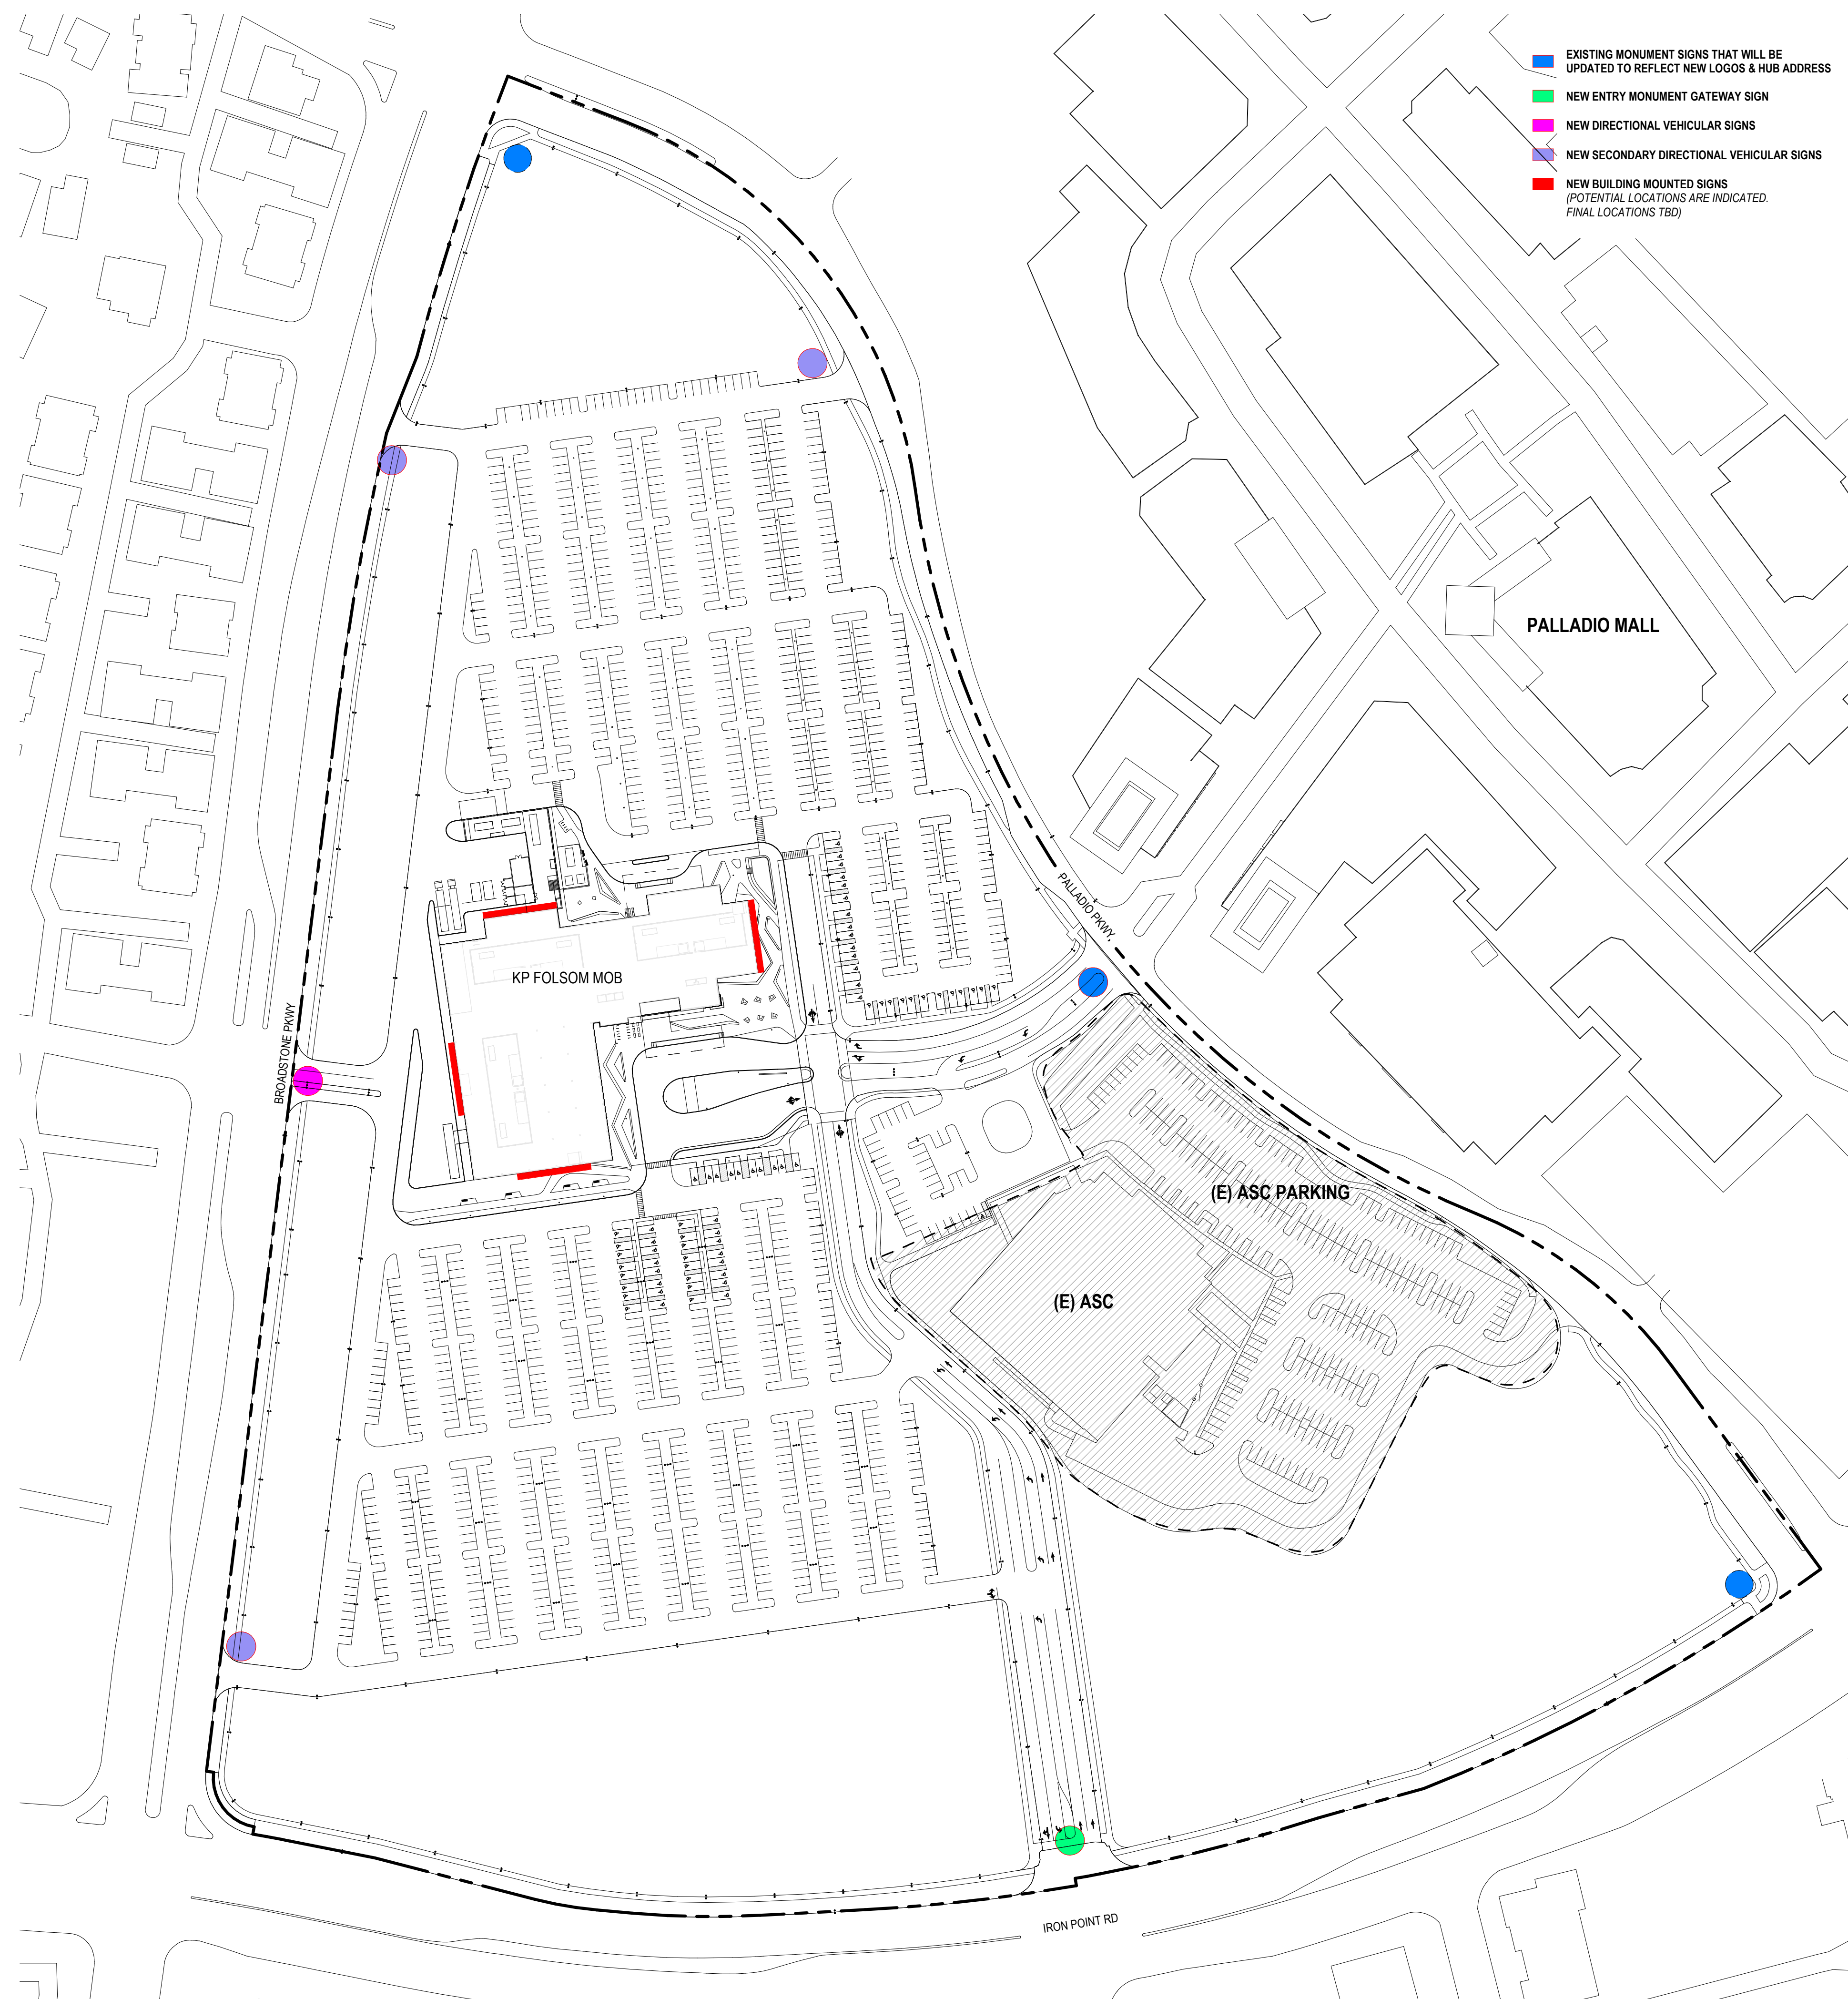

|                                                                                     |                                                                                           |
|-------------------------------------------------------------------------------------|-------------------------------------------------------------------------------------------|
|  | EXISTING MONUMENT SIGNS THAT WILL BE UPDATED TO REFLECT NEW LOGOS & HUB ADDRESS           |
|  | NEW ENTRY MONUMENT GATEWAY SIGN                                                           |
|  | NEW DIRECTIONAL VEHICULAR SIGNS                                                           |
|  | NEW SECONDARY DIRECTIONAL VEHICULAR SIGNS                                                 |
|  | NEW BUILDING MOUNTED SIGNS<br>(POTENTIAL LOCATIONS ARE INDICATED.<br>FINAL LOCATIONS TBD) |



**FOLSOM MOB**

285 Palladio Pkwy,  
Folsom, CA 95630

**SMITHGROUP**

550 SOUTH HOPE STREET  
SUITE 1950  
LOS ANGELES, CA 90071  
213.228.6900  
smithgroup.com

[illegible]

SEALS AND SIGNATURES

NOT FOR CONSTRUCTION

SHEET TITLE

## SIGNAGE TYPE AND LOCATION PLAN

13931.000

SHEET NUMBER

## 1-A1.3.2

|            |                      |        |
|------------|----------------------|--------|
| Plot Date: | 9/26/2022 9:17:12 AM | Author |
|------------|----------------------|--------|

Author



285 Palladio Pkwy,  
Folsom, CA 95630

550 SOUTH HOPE STREET  
SUITE 1950  
LOS ANGELES, CA 90071  
213.228.6900  
smithgroup.com

[illegible]

SEALS AND SIGNATURES

NOT FOR  
CONSTRUCTION

SHEET TITLE

## SITE LIGHTING PLAN - AREA A

PROJECT NUMBER [13931.000]

## 1-AL1.1.1

SHEET NUMBER



1 LEVEL 1 - SITE PLAN AREA A  
SCALE: 1/64" = 1'-0"





85 Palladio Pkwy,  
olsom, CA 95630

350 SOUTH HOPE STREET  
SUITE 1950  
LOS ANGELES, CA 90071  
213.228.6900  
smithgroup.com

SEALS AND SIGNATURES

NOT FOR  
CONSTRUCTION

PROJECT NUMBER [13931.000]

SHEET NUMBER



1 LEVEL 1 - SITE PLAN AREA B  
SCALE: 1/64" = 1'-0"



